

Floris+Design

Technical Projects Workflow

FLORIS+DESIGN

Perluigi Floris
ARCHITETTO




2D Phase


Development of 2D drawings for construction site use

2D Drawings


Architectural 2D documents

In this phase, we develop the 2D architectural drawings. It embodies a precise and standardized language for comprehensively and graphically portraying an interior design project. In this way every supplier can receive all the information to complete the project.

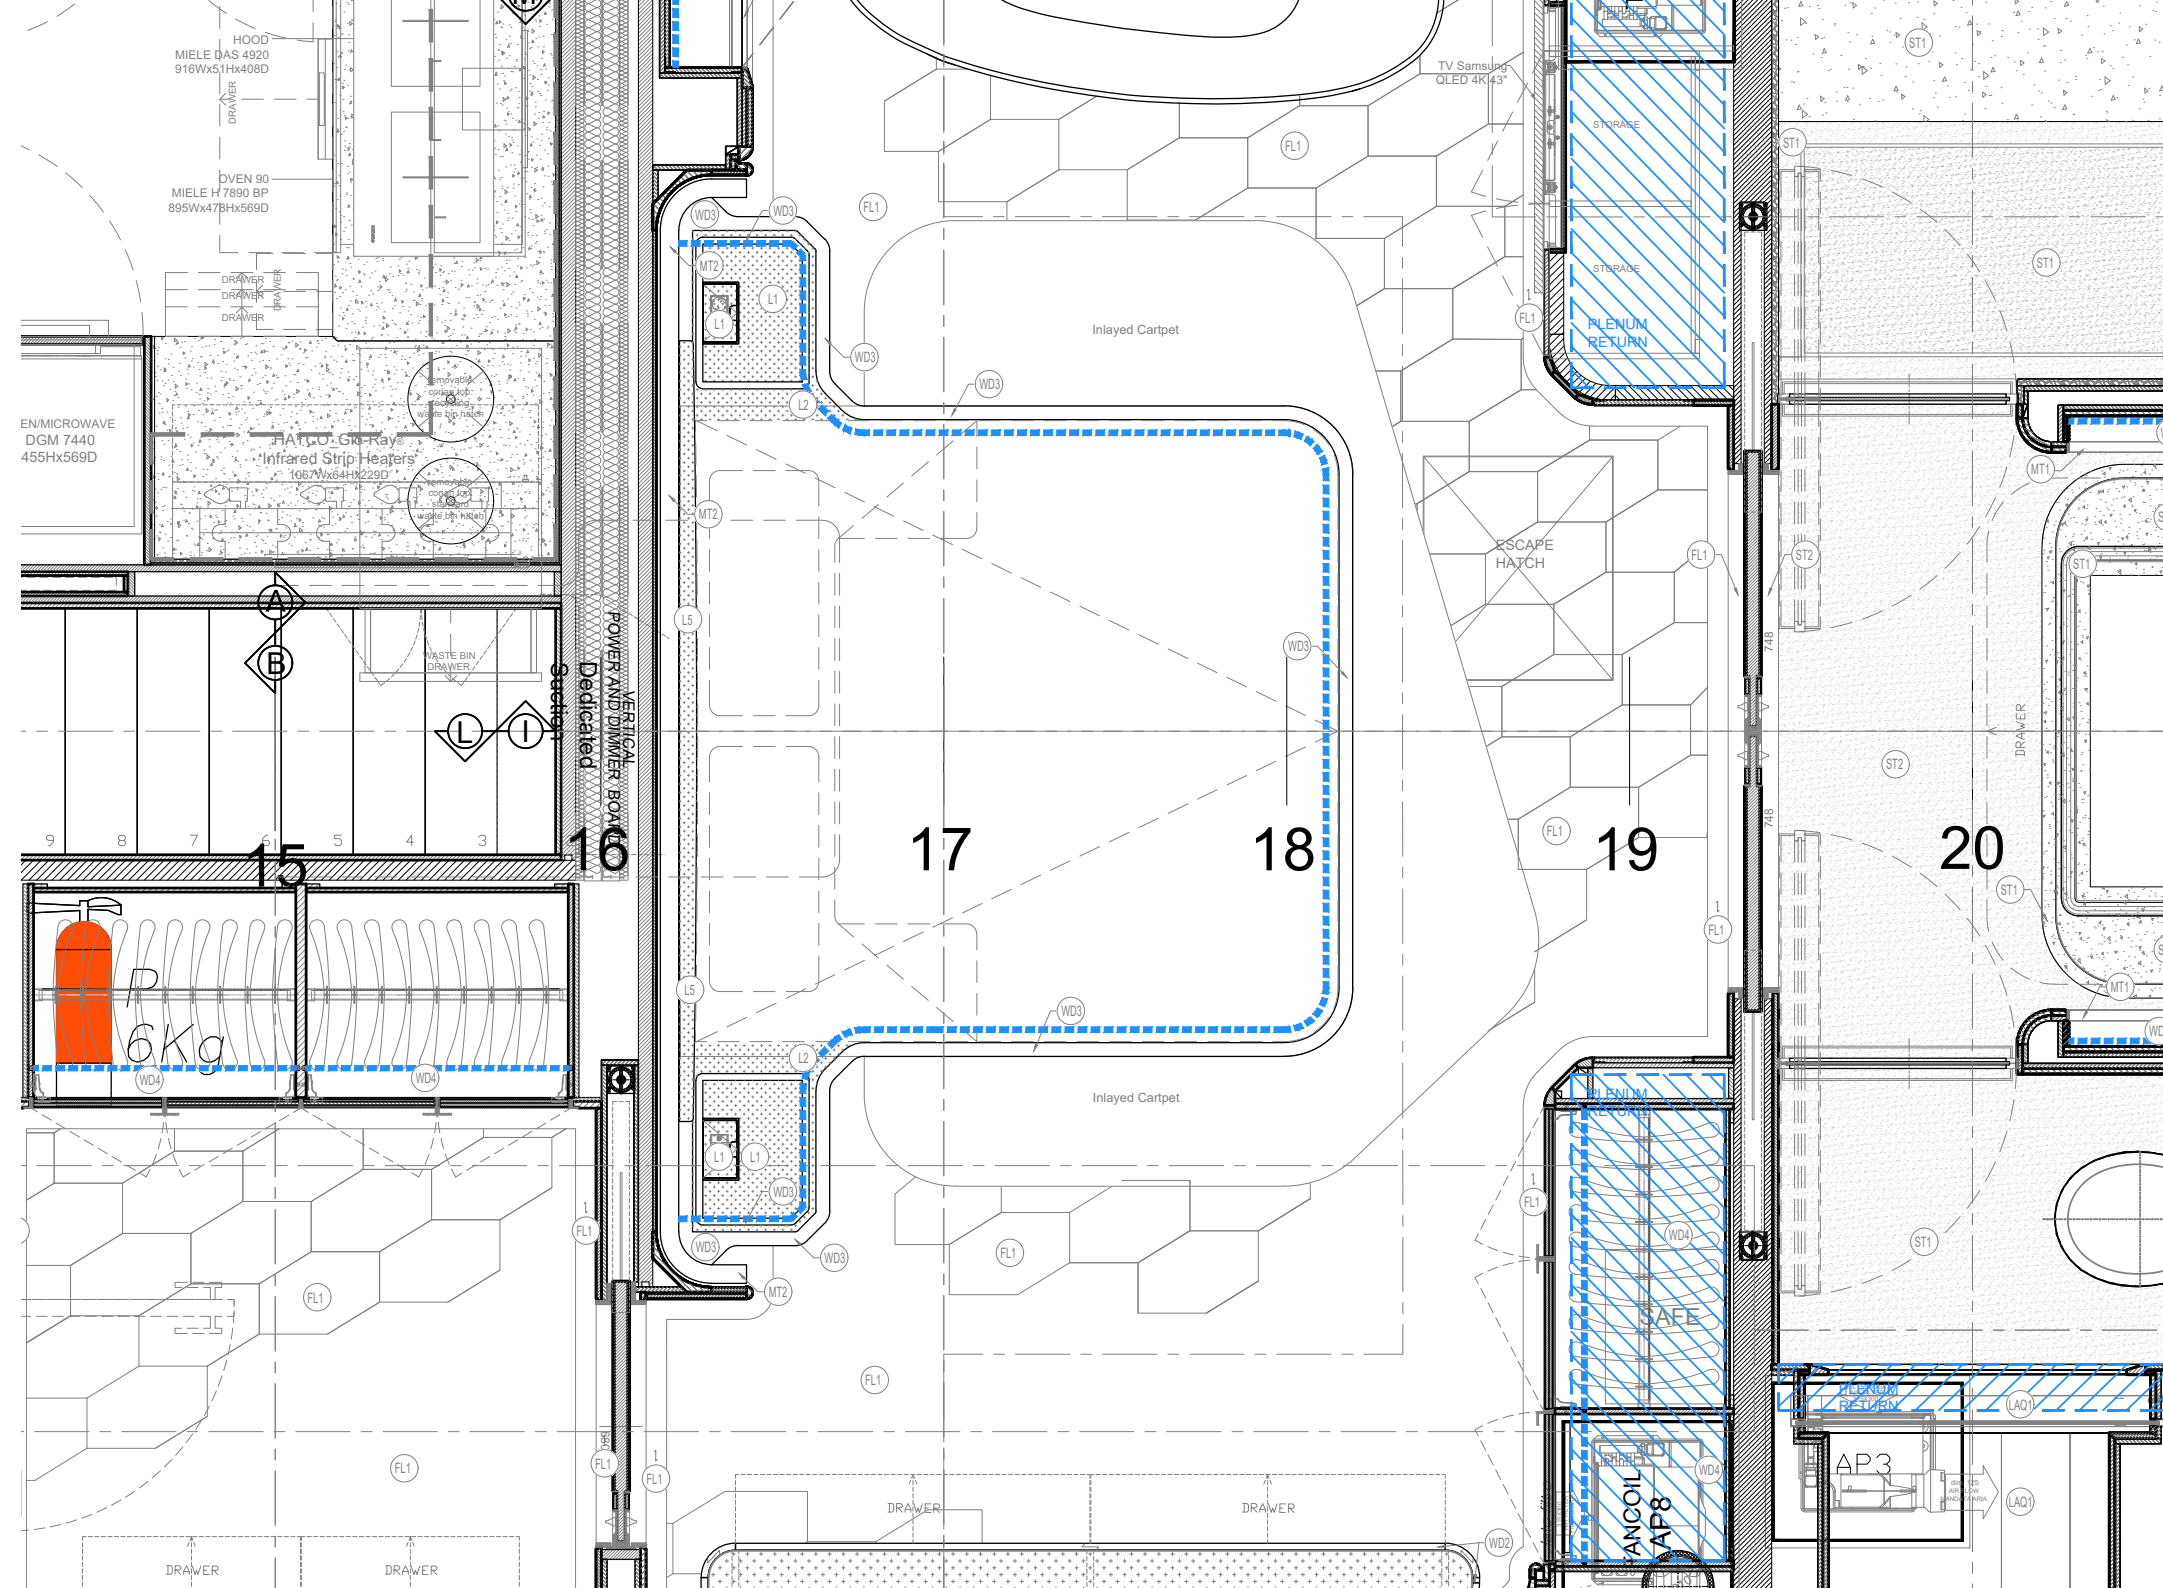

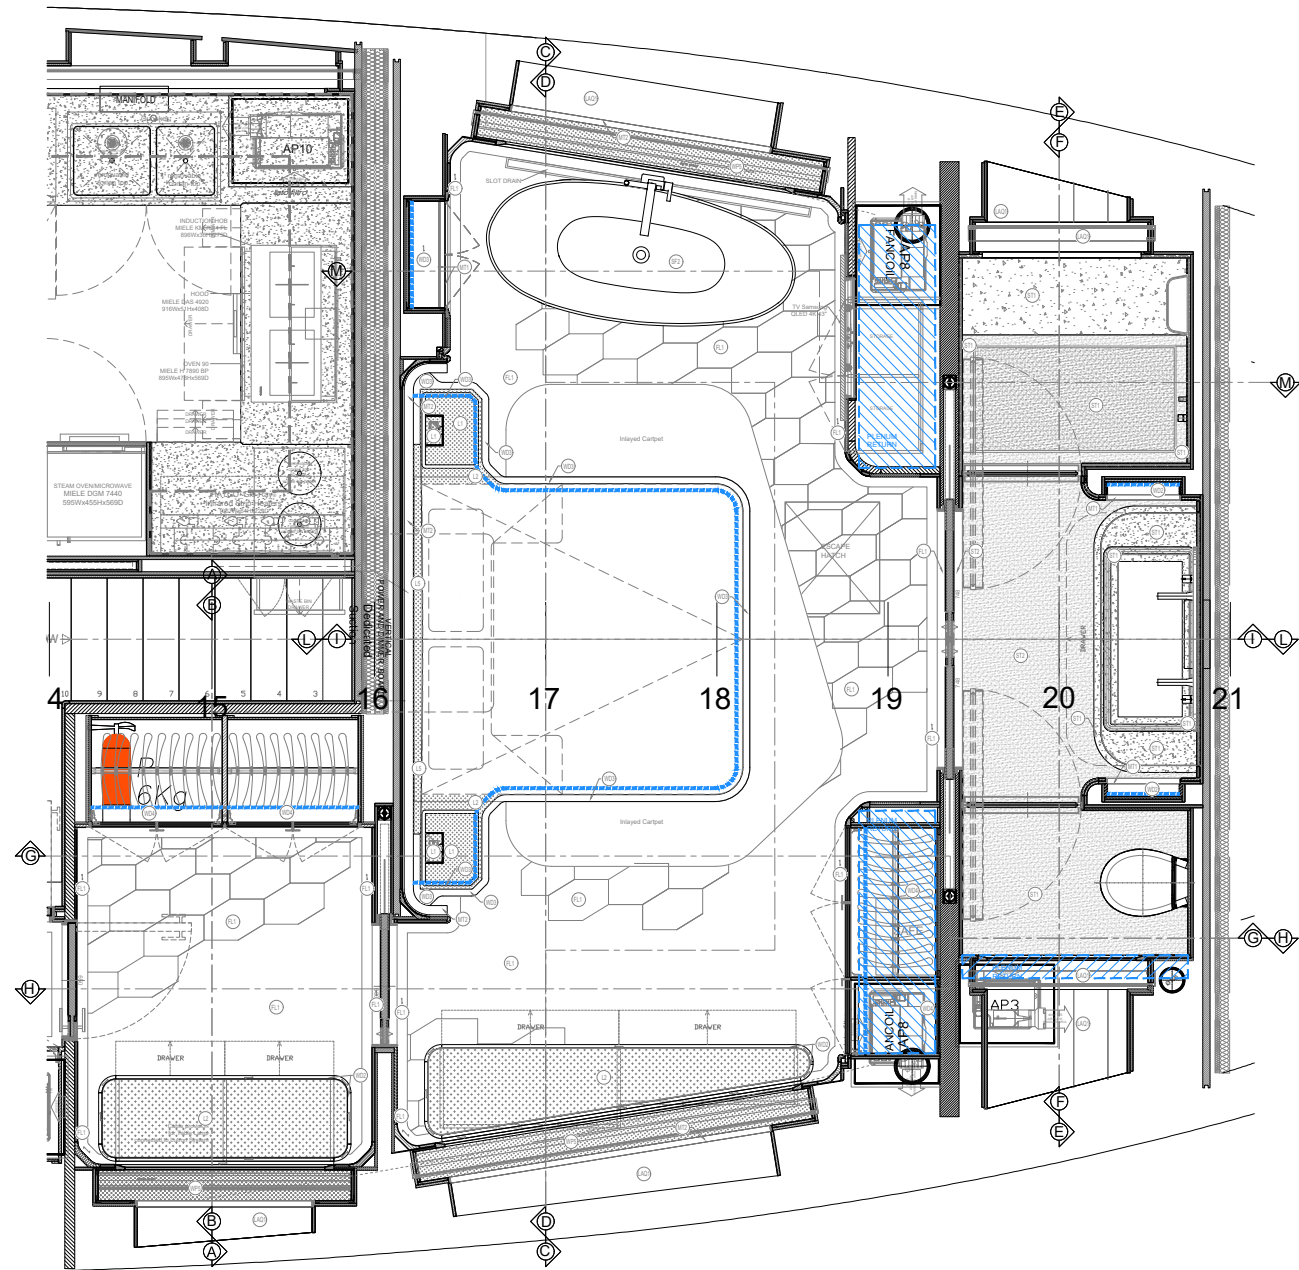


1 PLAN VIEW
Scale: 1:20

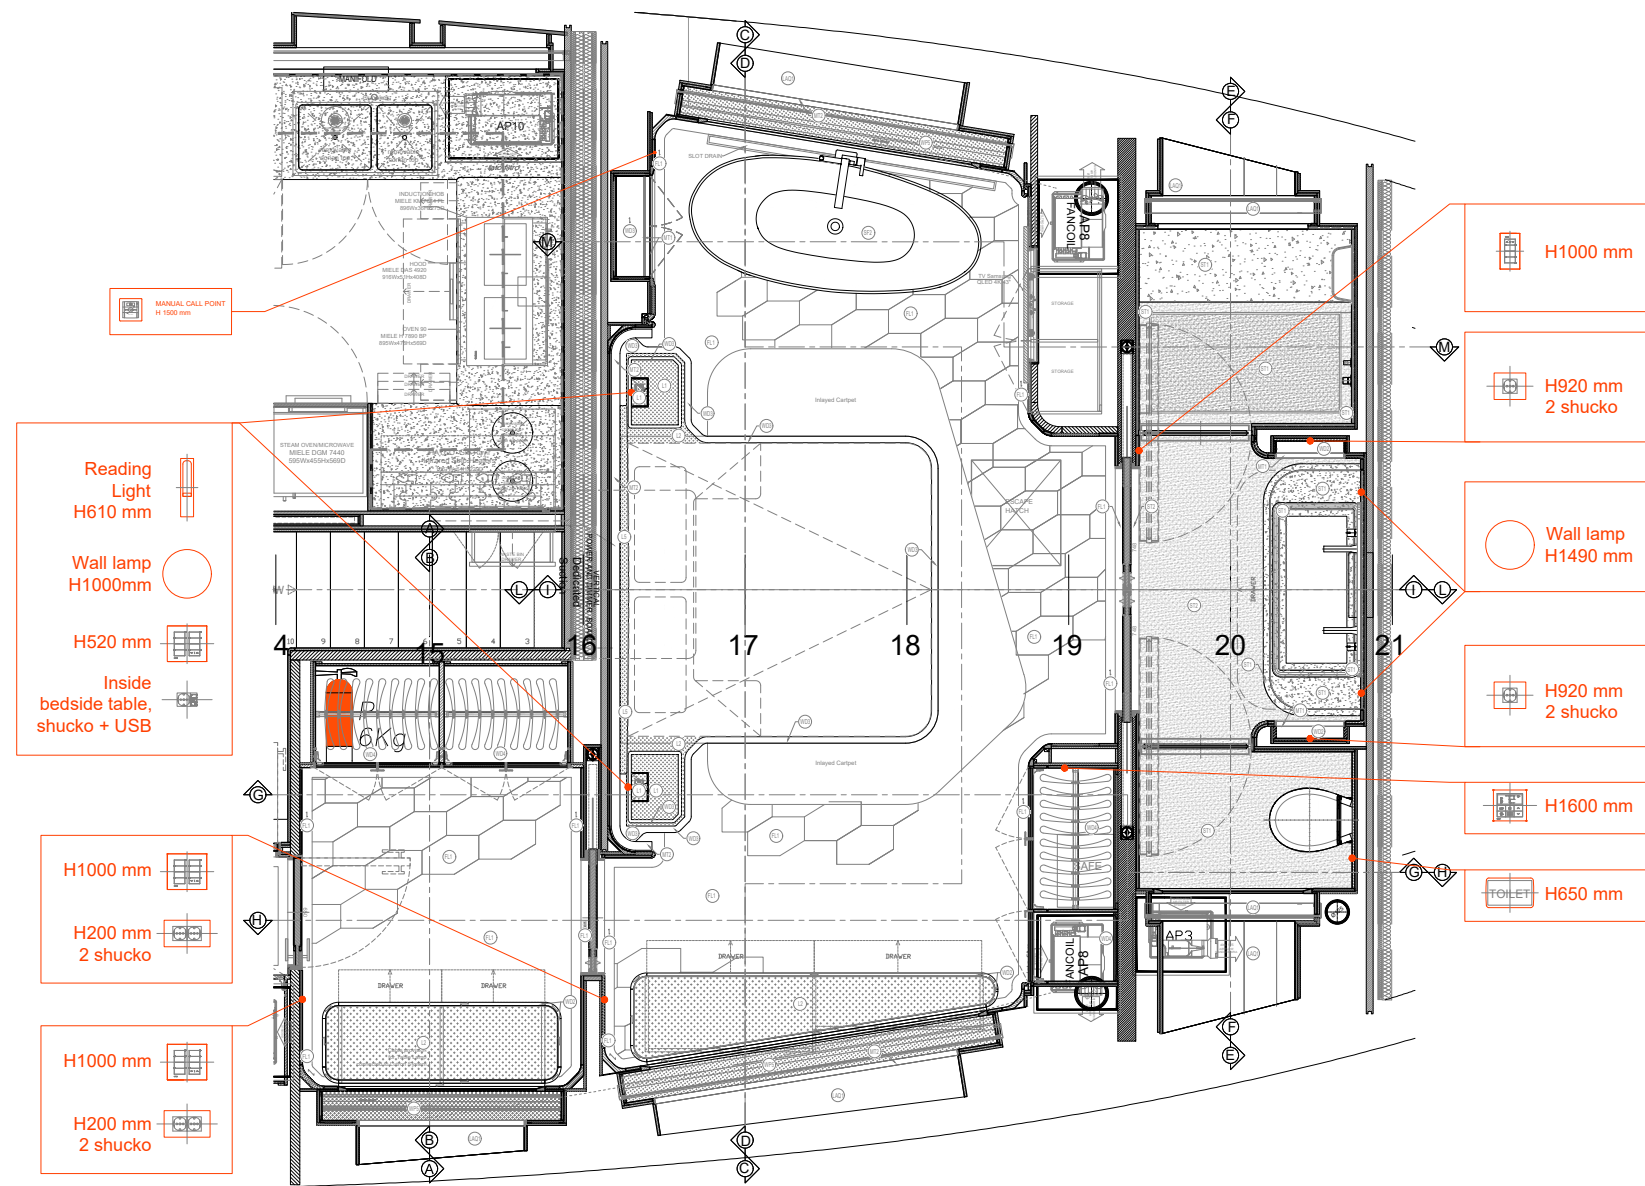


3 ELECTRICAL PLAN
Scale: 1:20

FR. 17

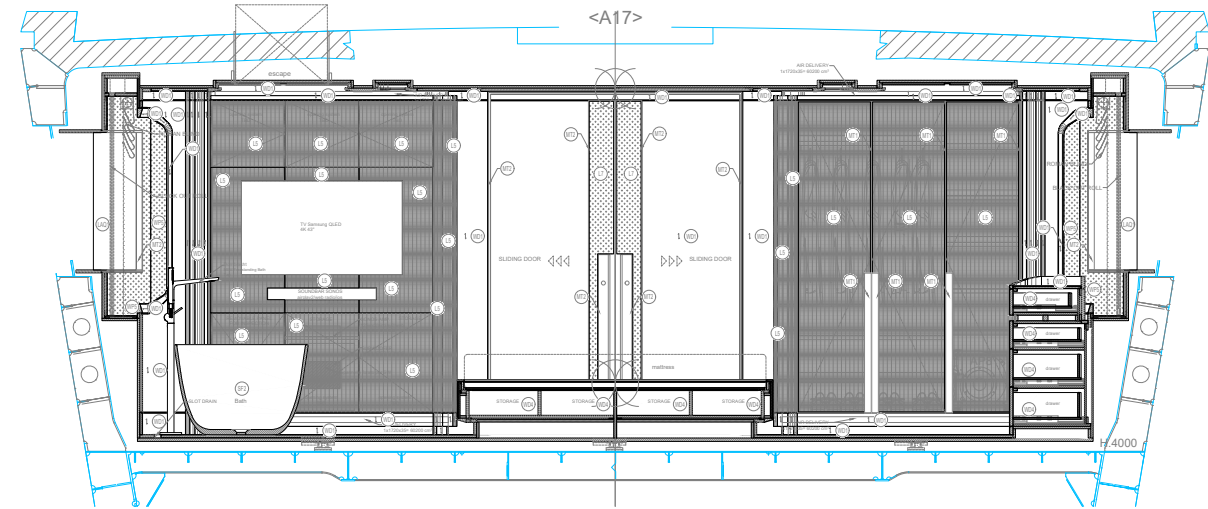


6 SECTION C
Scale: 1:20

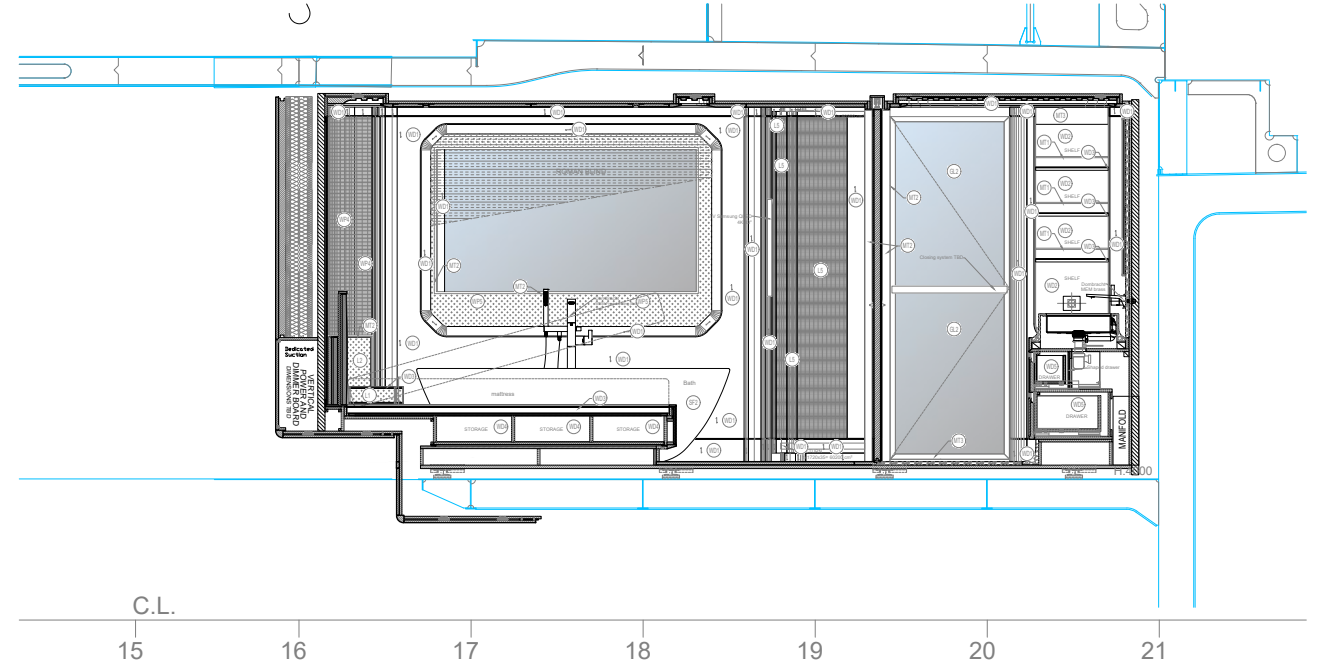


12 SECTION I
Scale: 1:20


FRAME 17 AFT

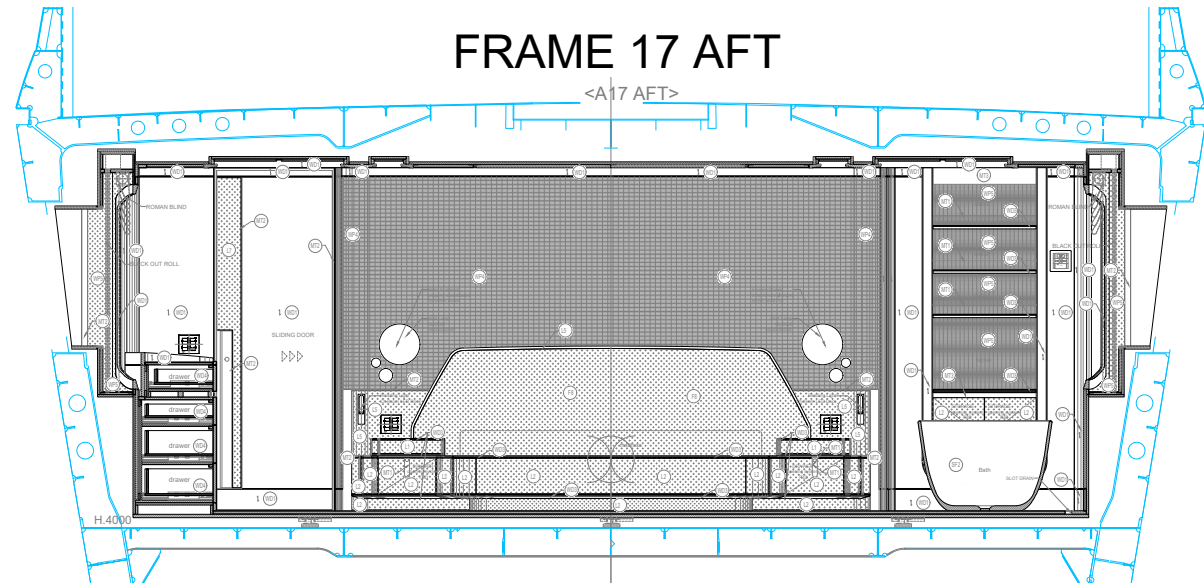

7 SECTION D
Scale: 1:20

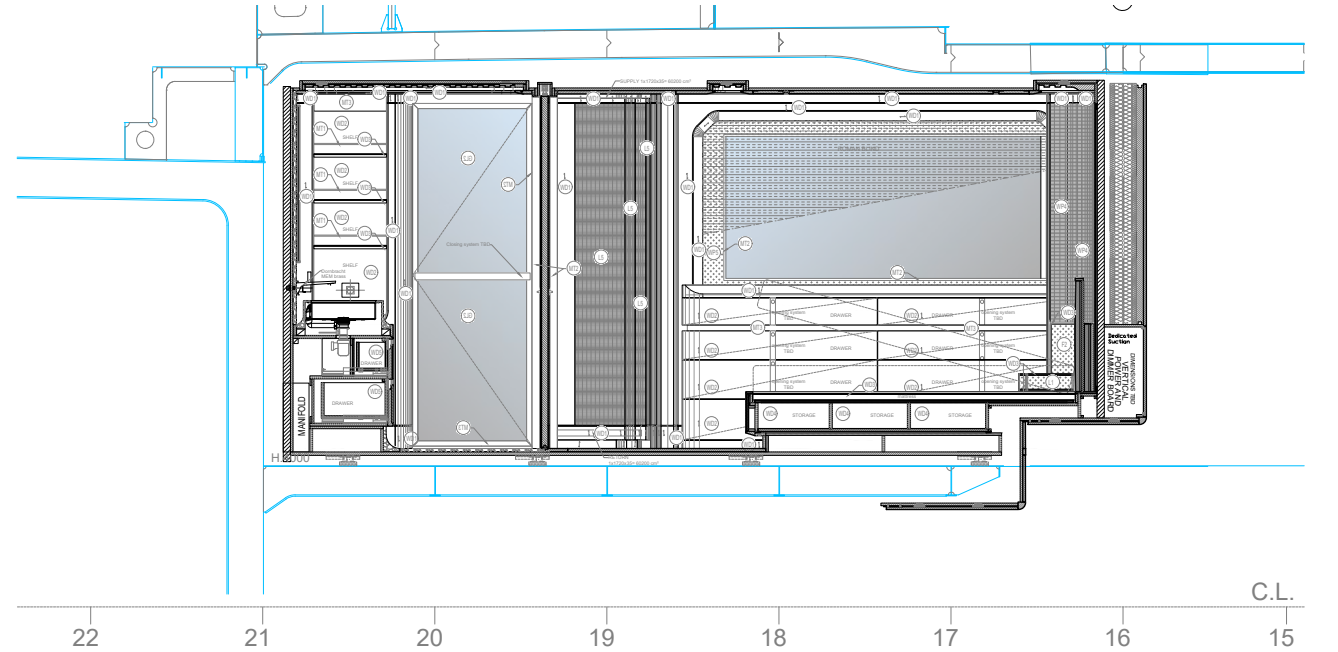

12 SECTION I
Scale: 1:20

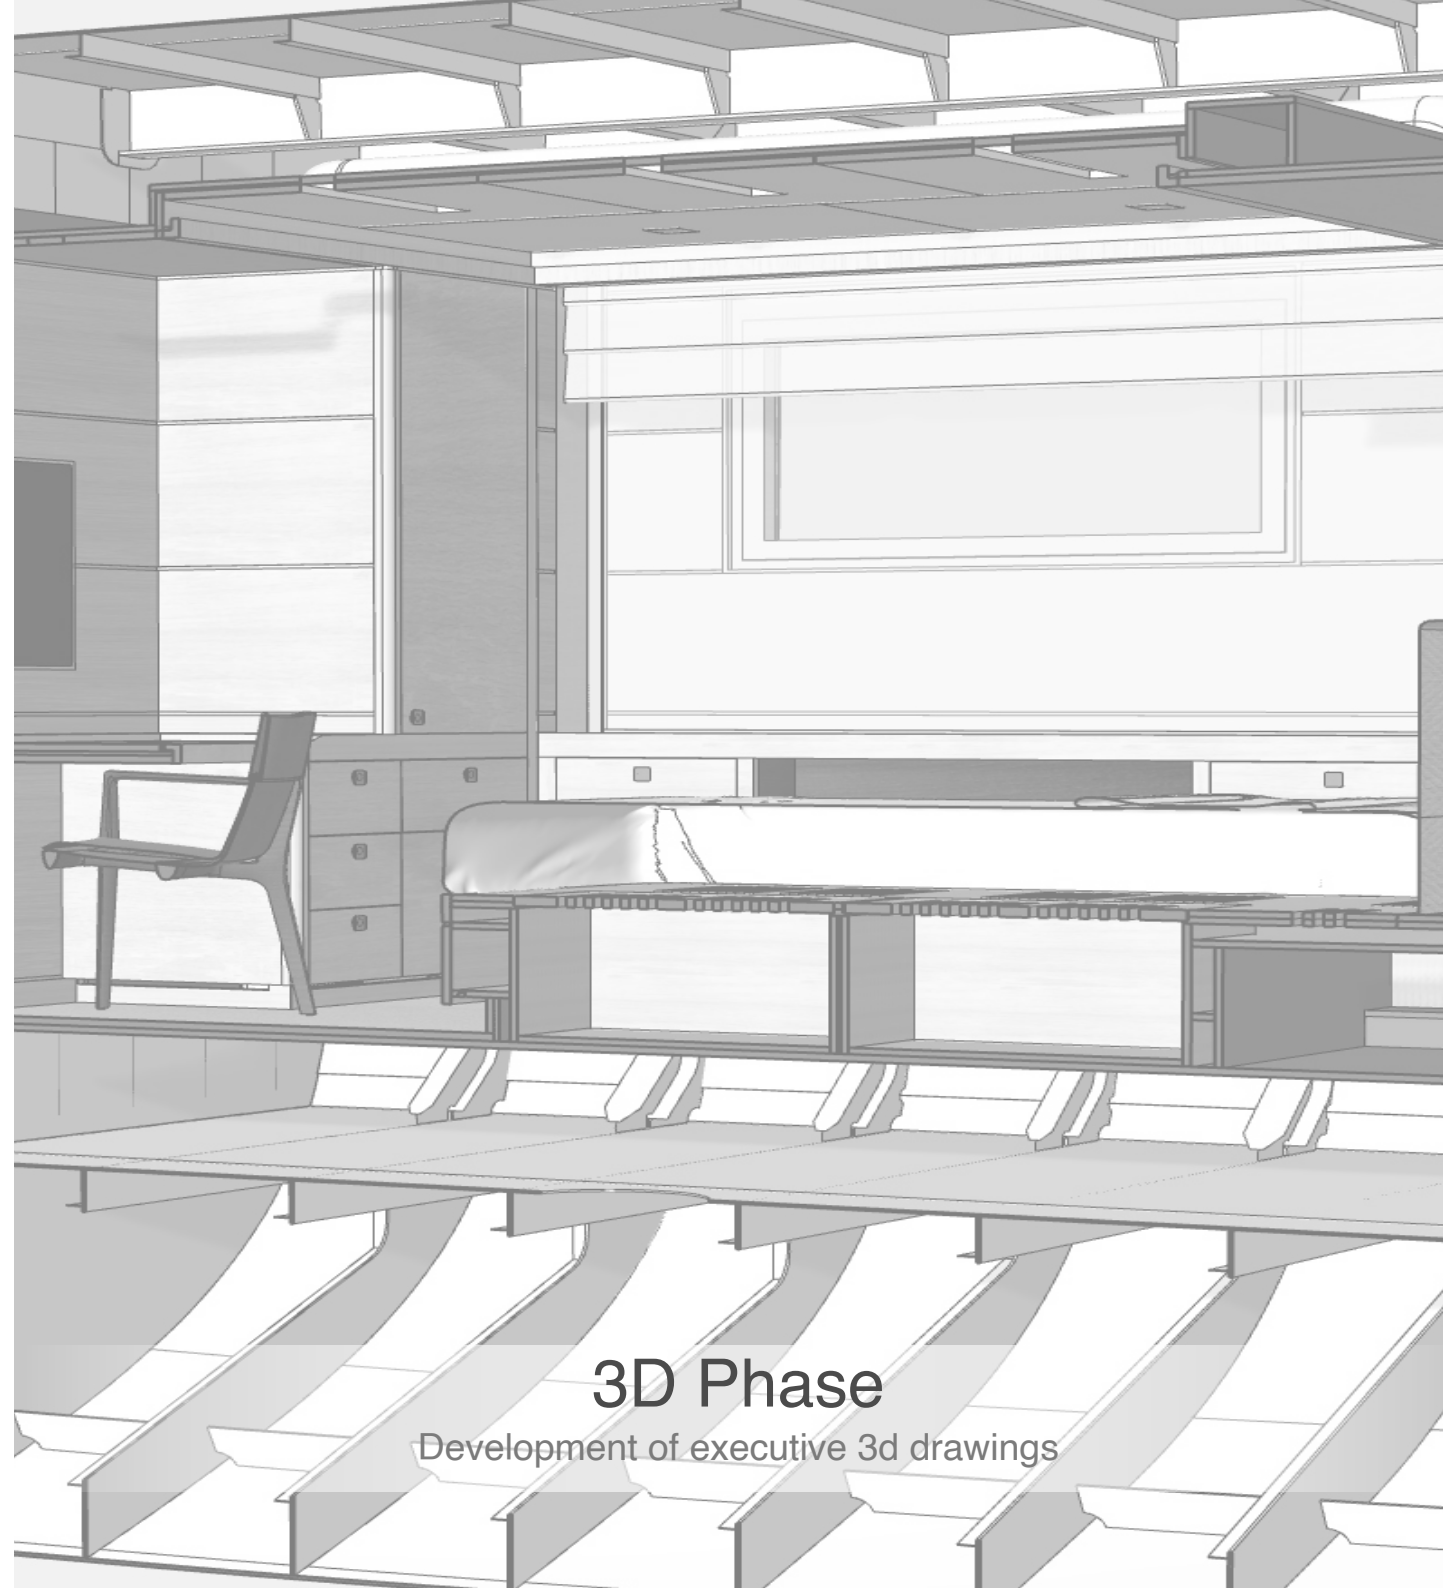

3D Phase


Development of executive 3d drawings


Interior 3D models



Project Development

*Every project is developed in 3D.
This process allows us to analyze the
different areas with a very high degree
of detail that
guarantees greater precision during the
render phase,
production phase and assembly
of the interiors.*



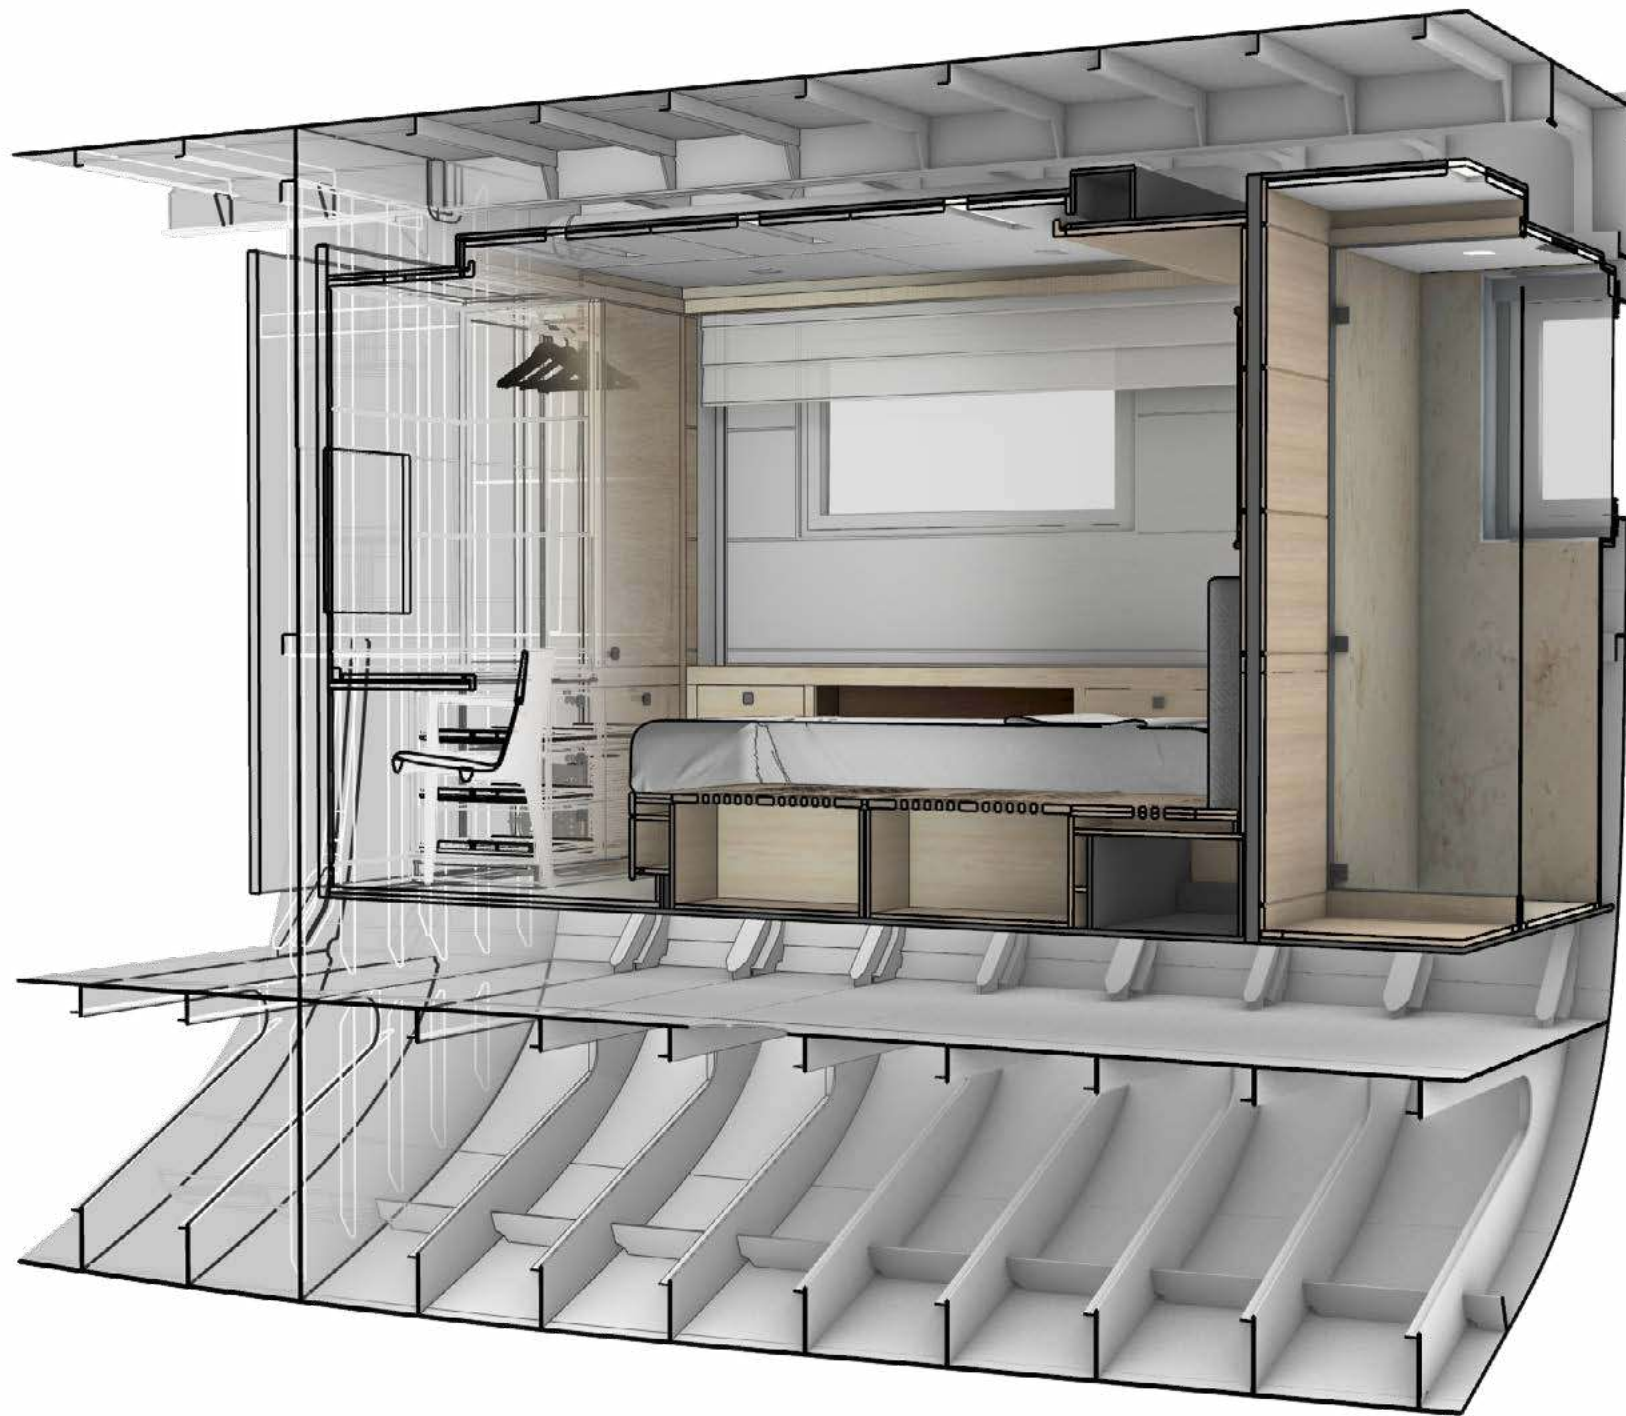

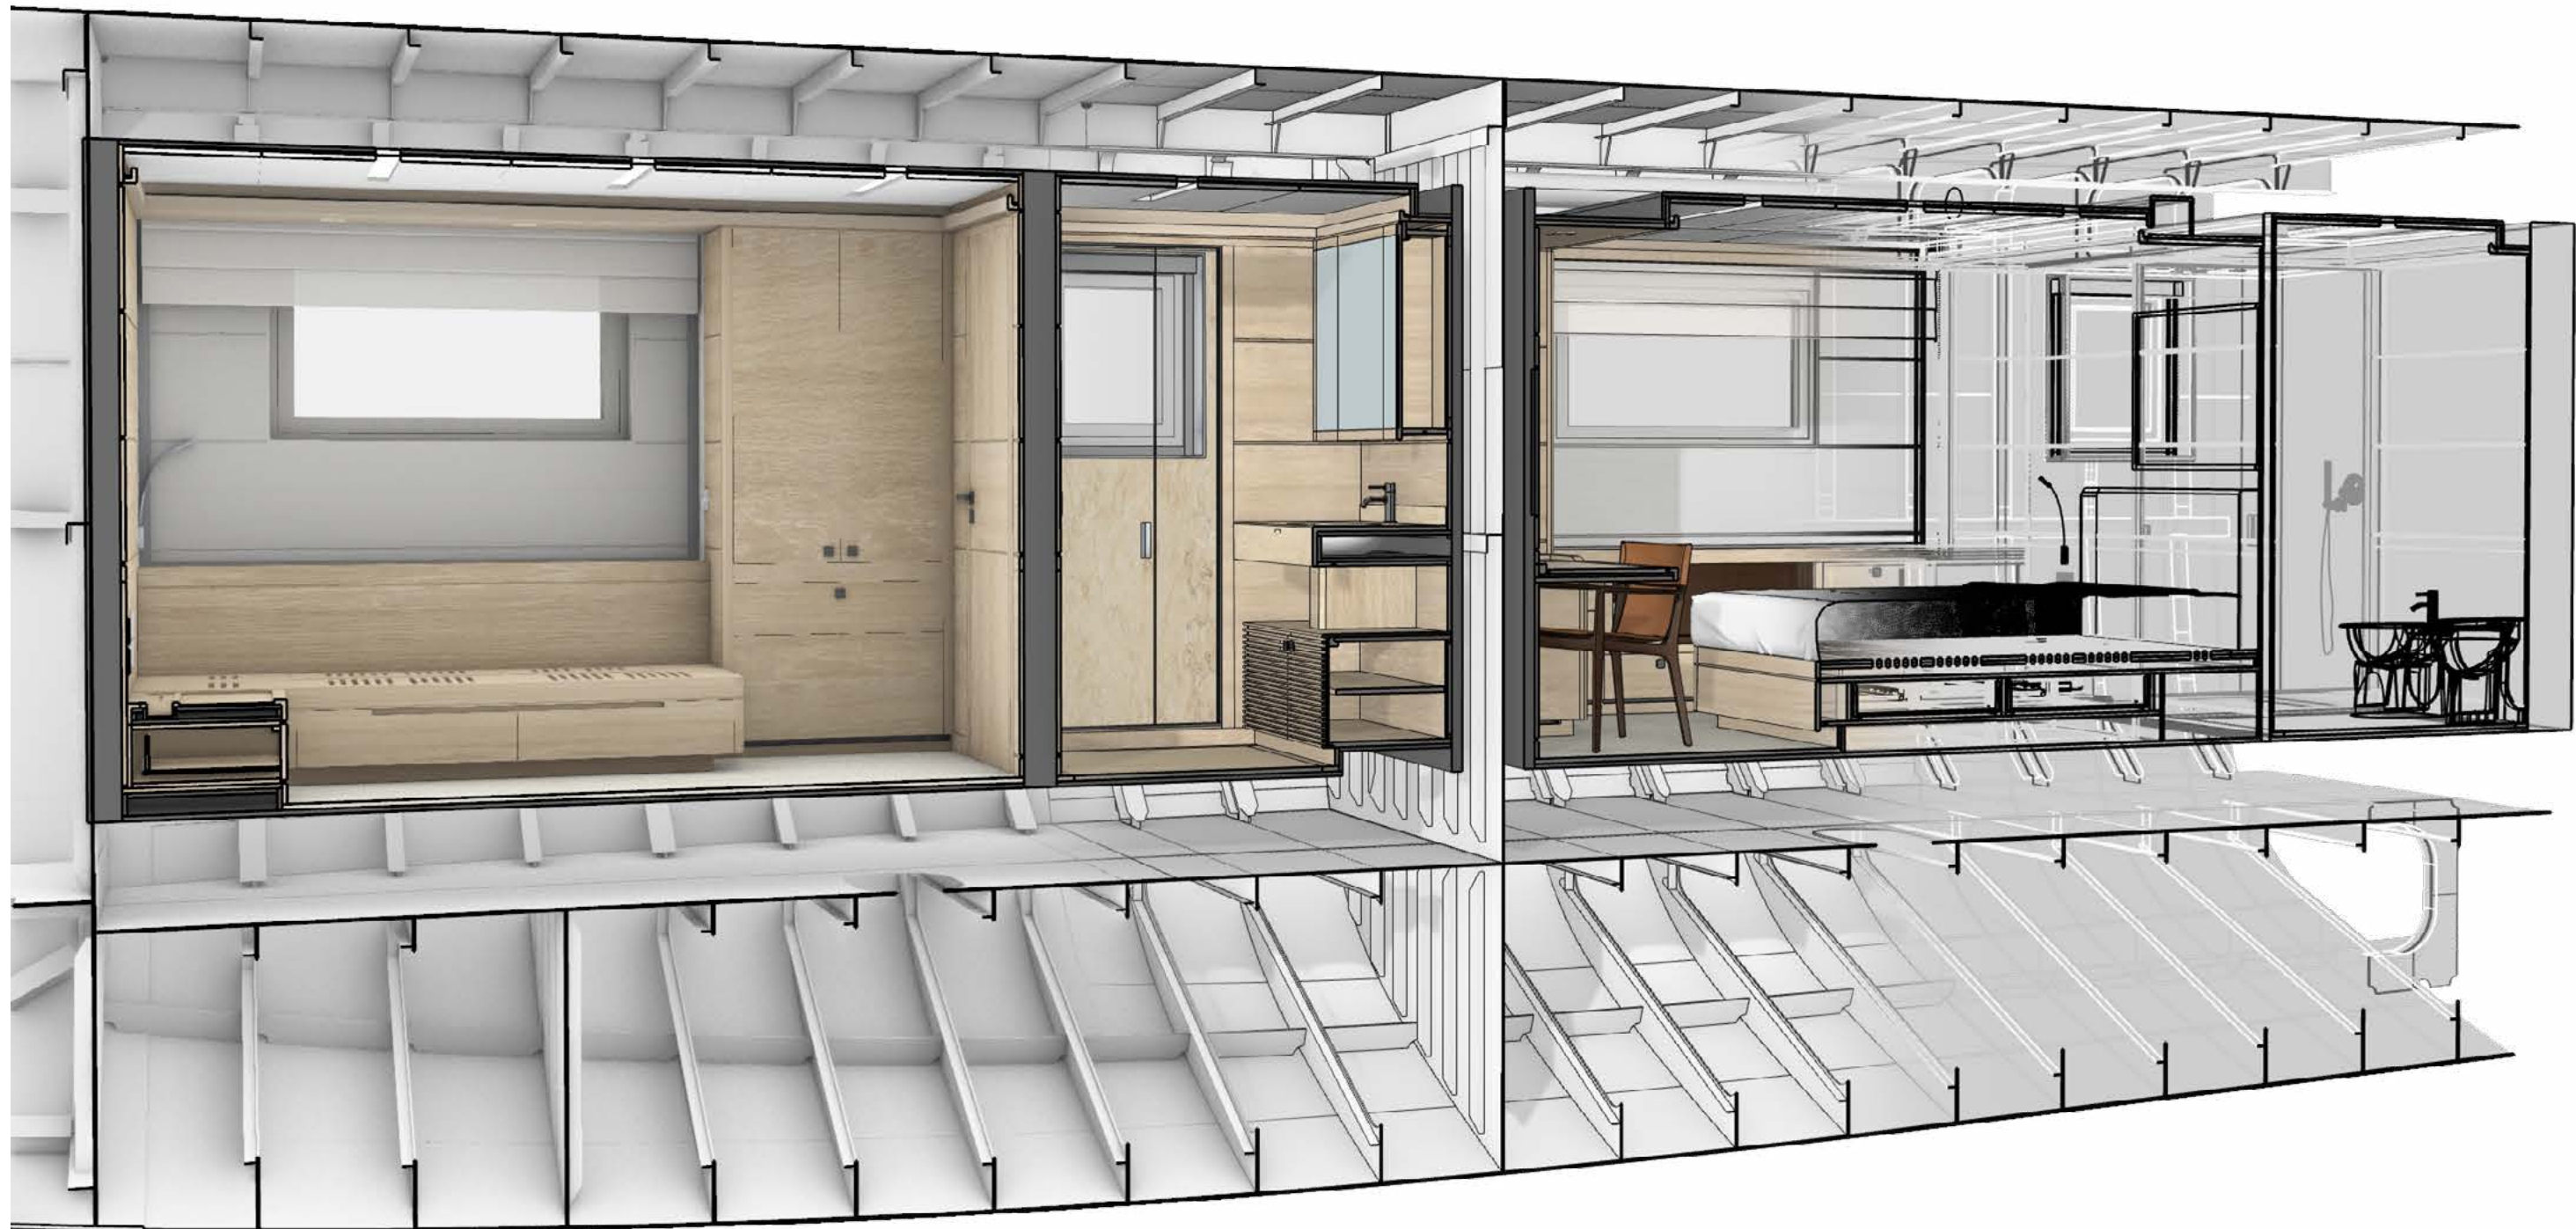

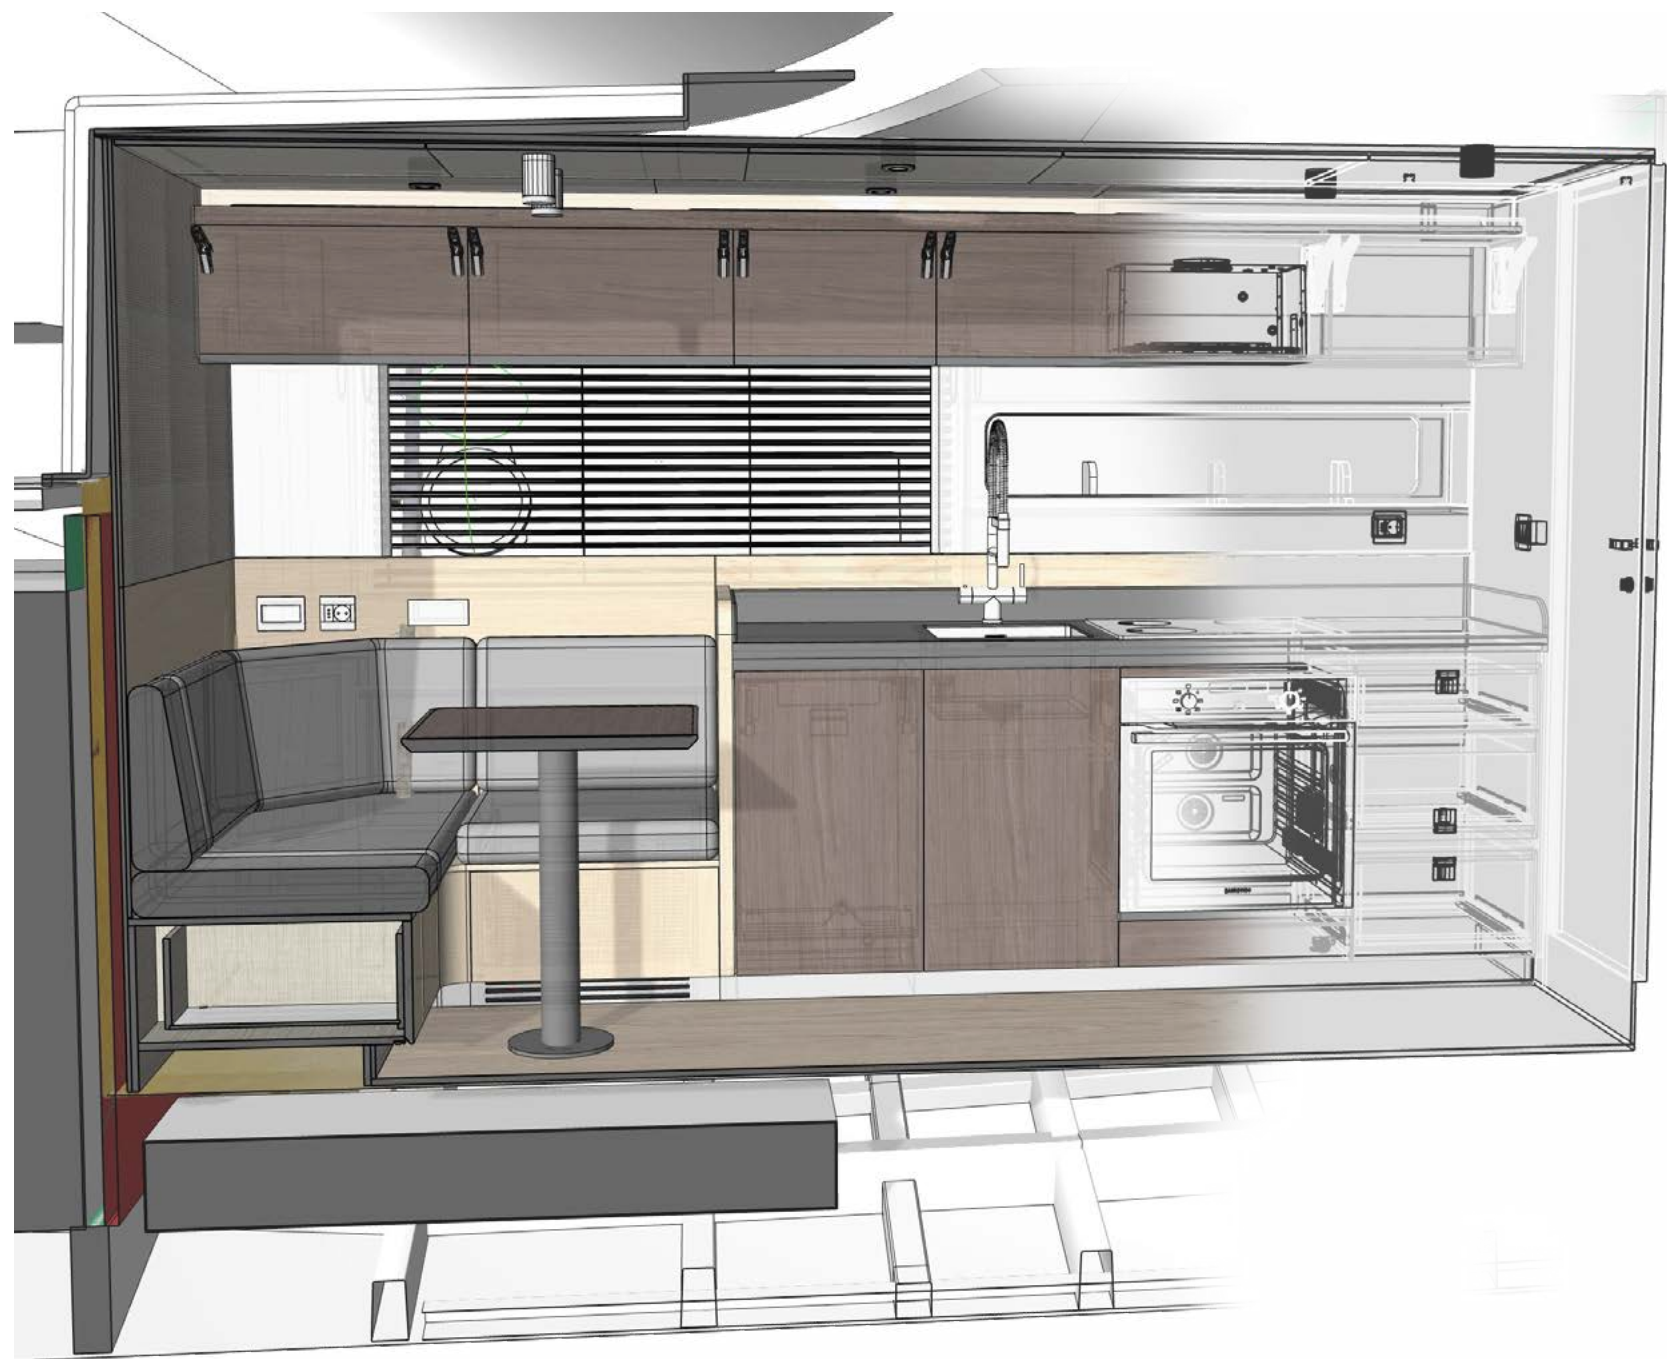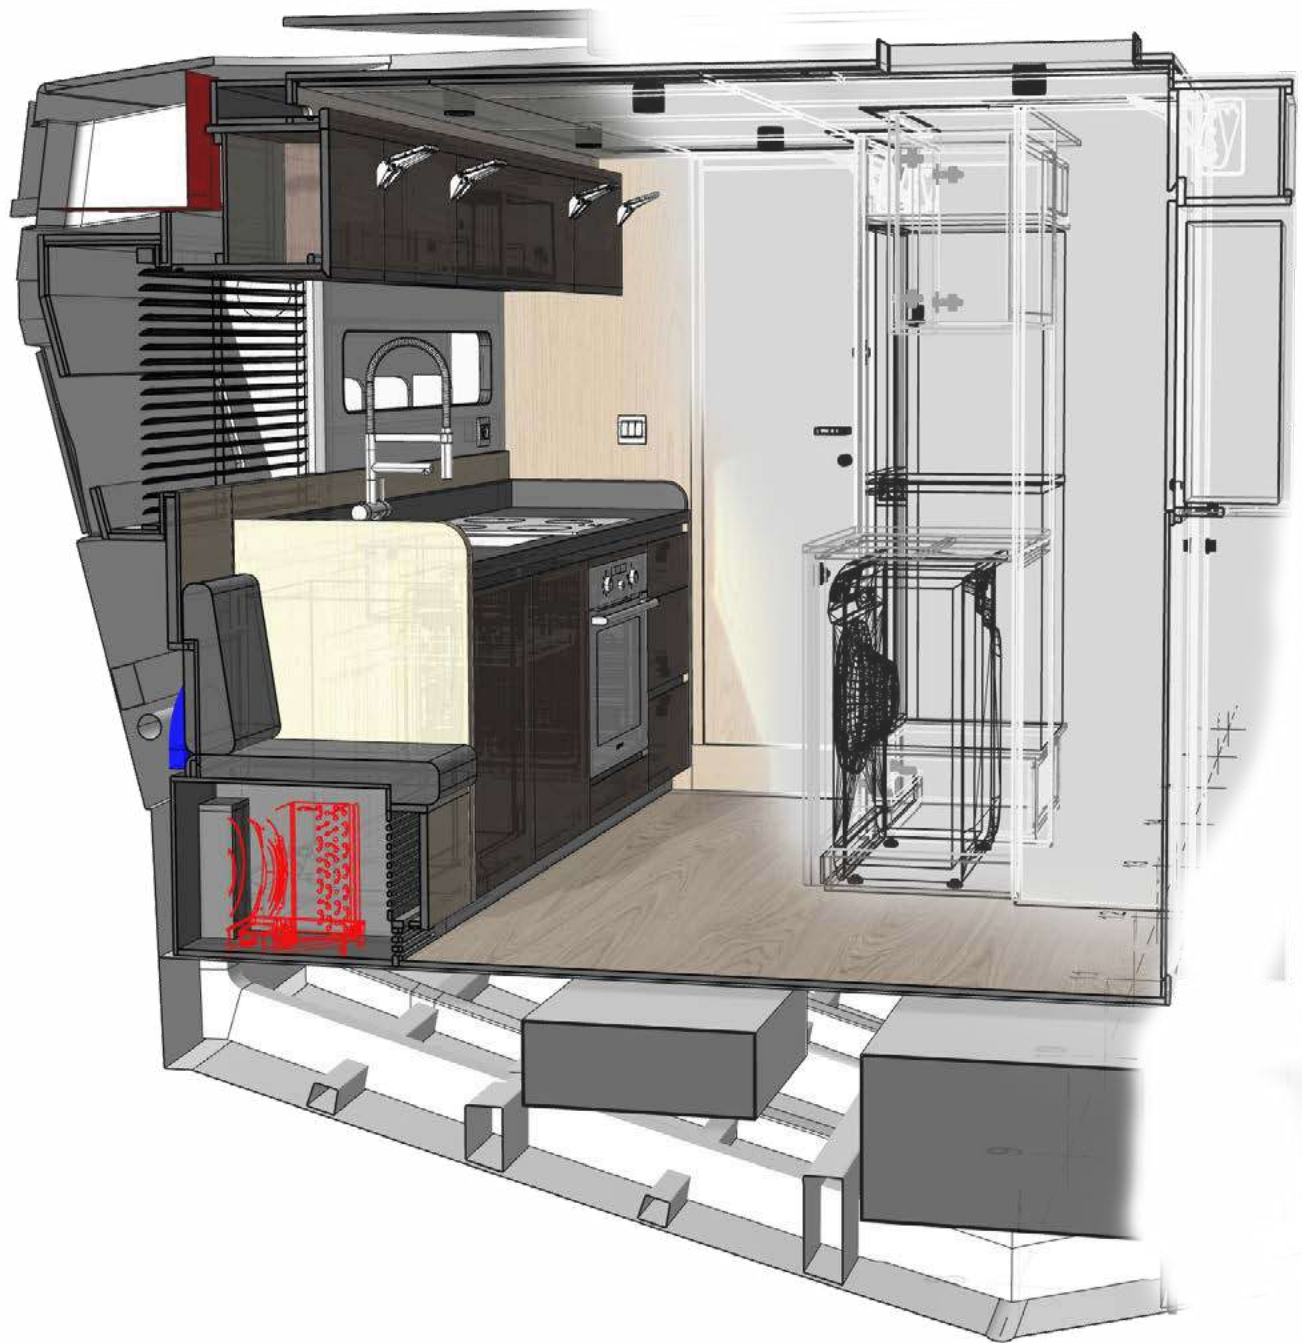

FLORIS+DESIGN

Pierluigi Floris
ARCHITETTO

www.florisdesign.it

Sede legale e Sede Operativa Via Nolfi 5C, 61032 Fano (PU) Italy_Direct Line +393282930715_info@florisdesign.it